



REFERENCE NUMBER

FUL/2019/3161&

ADV/2019/2729

SITE:

SCALE 1:1250


**OLD FIRE STATION
HALES STREET**

HALES STREET

**The Old
Fire Station**

**EI Sub
Sta**

L Twr

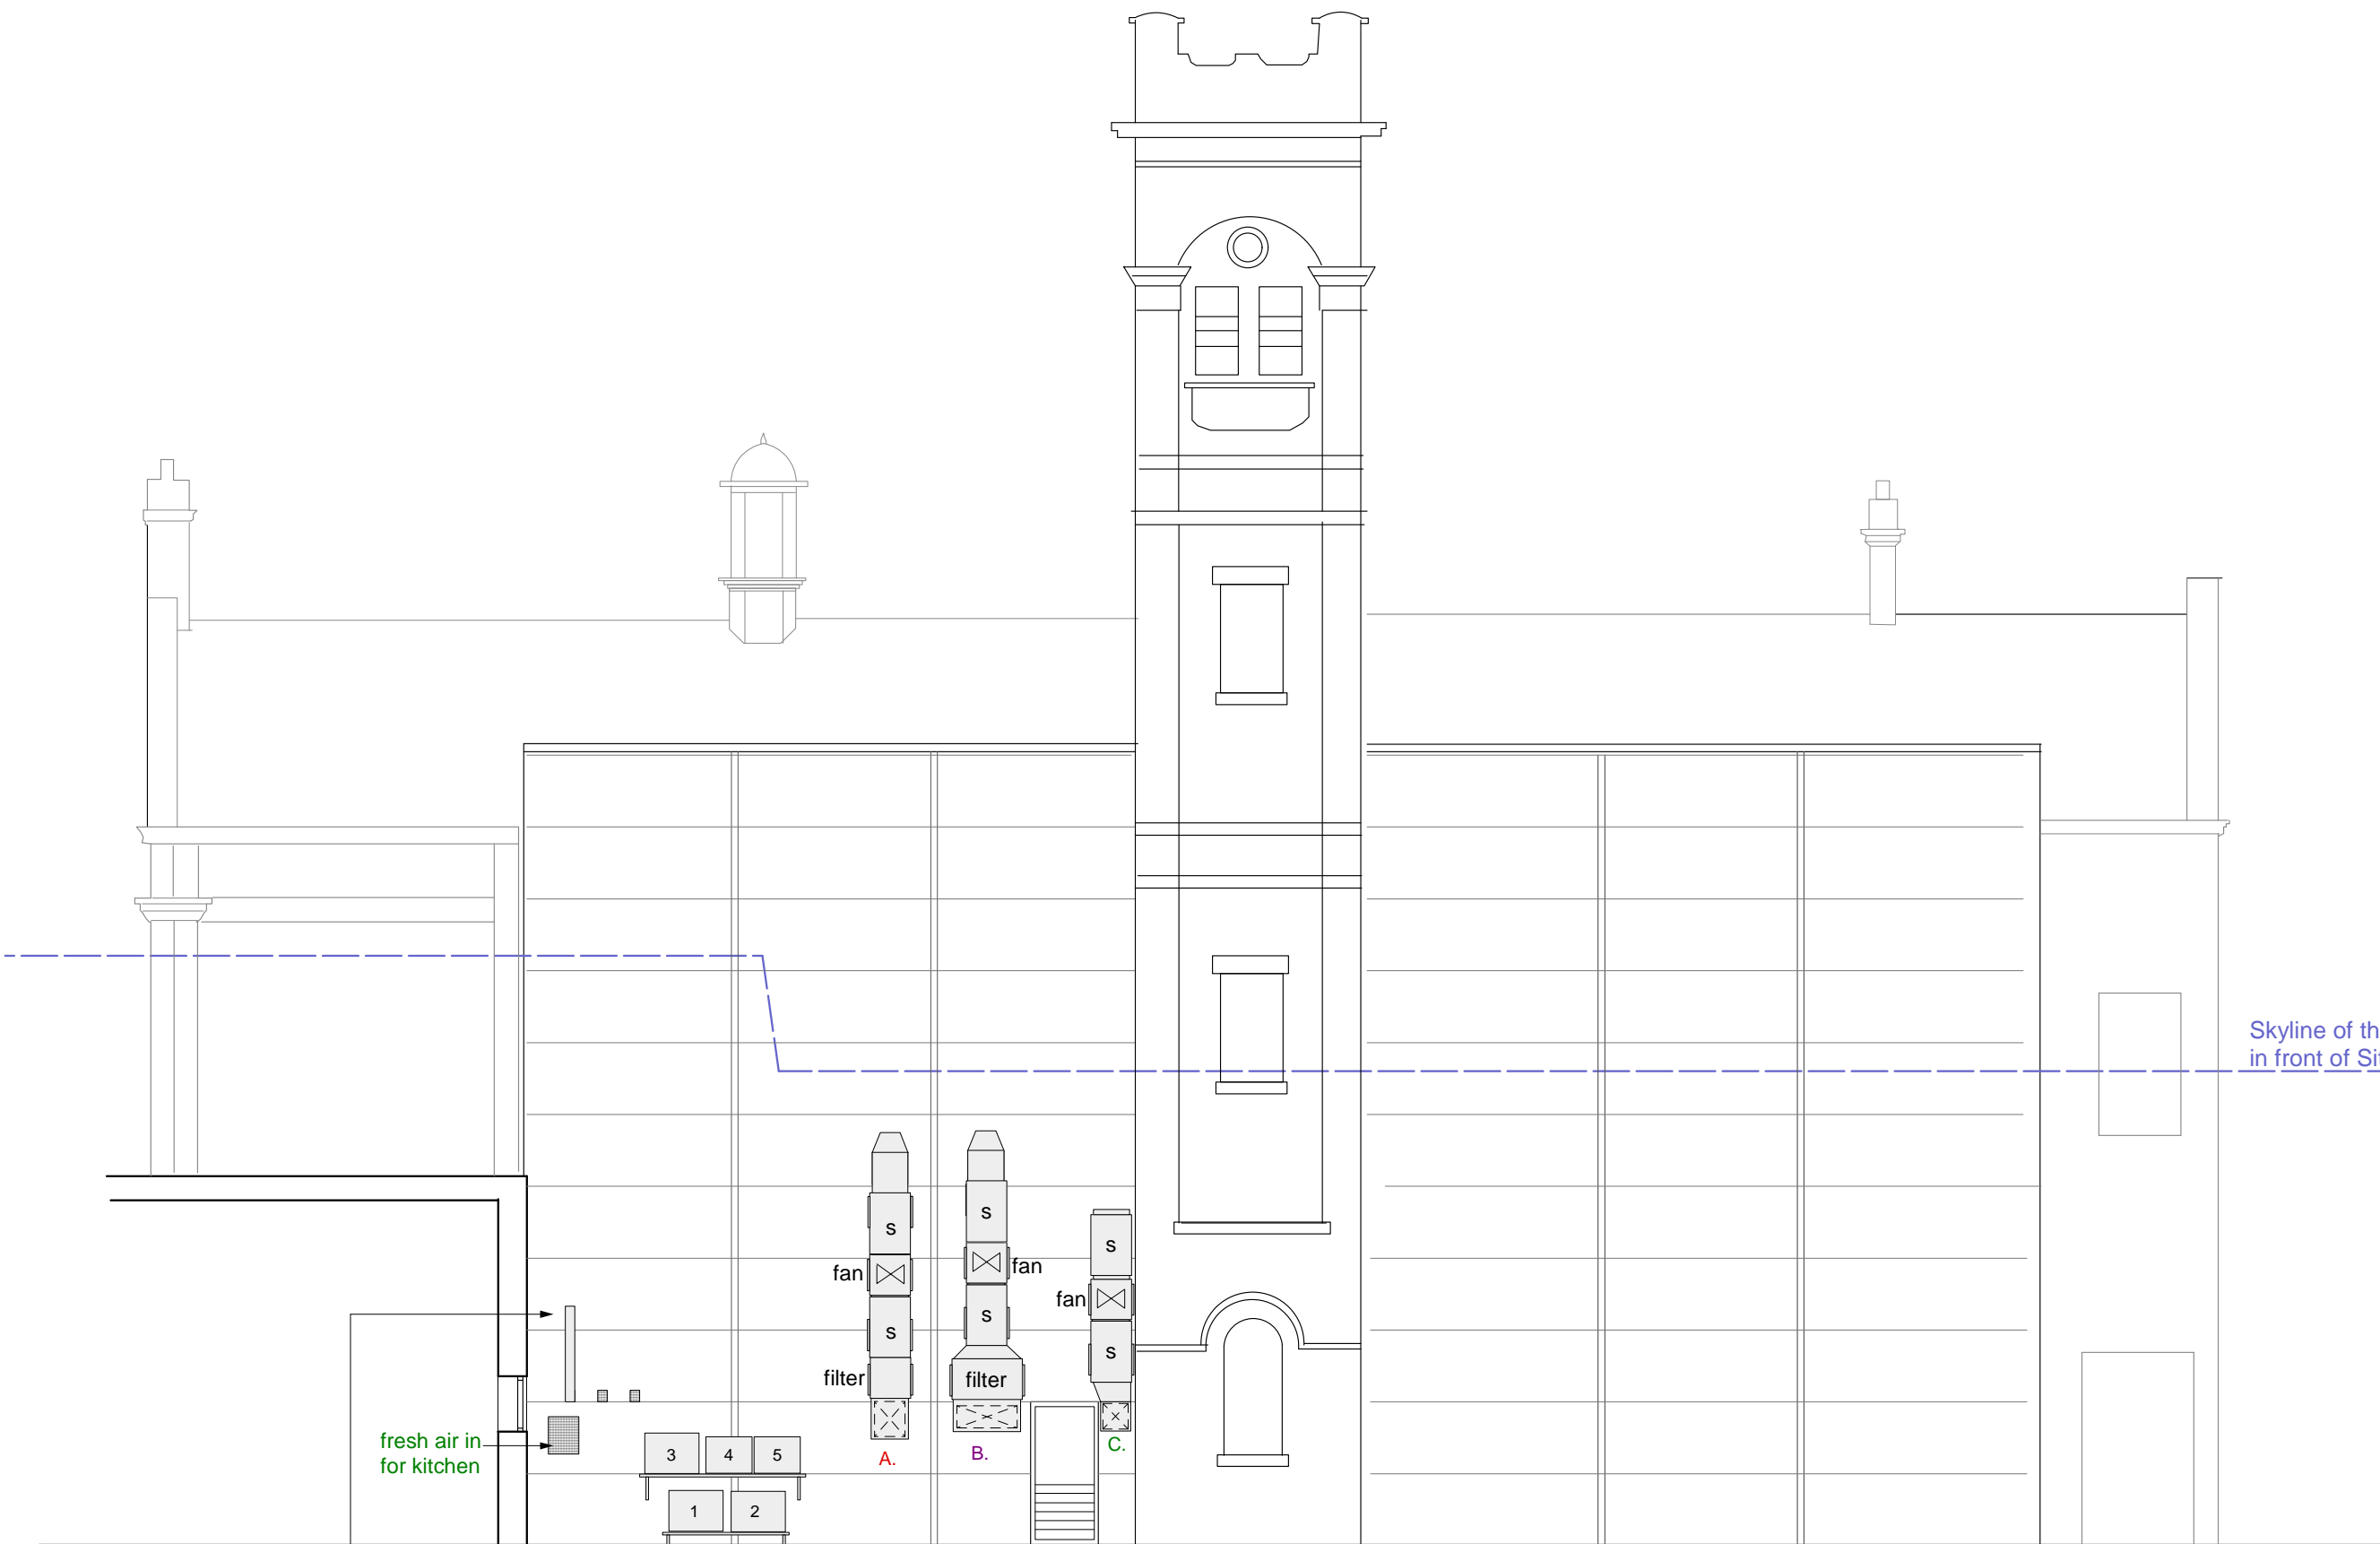

Skyline of the Station Building in front of Site Building

fresh air in for kitchen

air out vent and ducting connected to toilet area extraction fans; vent pipe to rise up min 1 meter from fresh air intake vents and adjoining window

air conditioning outdoor units and condensers for cold/freezer room

1,2 & 3 : Fujitsu AOYG14LAC2

4 & 5: 1 No. E150L-B Condenser unit and 1 No. E1150H-B Condenser unit

A. new extraction system for kitchen
Fan to be FlakeWoods 45JMv/16/4/6/28

Purified Air double pass carbon filter unit.
single collector cell model ESP 1500EI

B. new extraction fan & filters connected to restaurant extraction ducting system; min 12 air change/ph for restaurant
Fan to be FlakeWoods 50JMv/20/4/6/30

Purified Air double pass carbon filter unit.
2 collector cells model ESP 3000EI

C. new air in ventilation fan & ducting on high level along wall; fan to supply 75% fresh air in for restaurant area; model to be FlakeWoods 45JMv/16/4/6/28

NEW IMAGE DESIGN
2A Tiverton Road
London N18 1DW
Tel: 02083456883


Project Site: SHU XIANG GE
The Old Fire Station
Hale Street
Coventry CV1 1JA

Client: [REDACTED]

Drawing Title:
Proposed Back Elevation

Drawing No.:
518/PL/06

Date: Dec/2019	Scale: 1:100 @ A3	Rev:
-------------------	----------------------	------

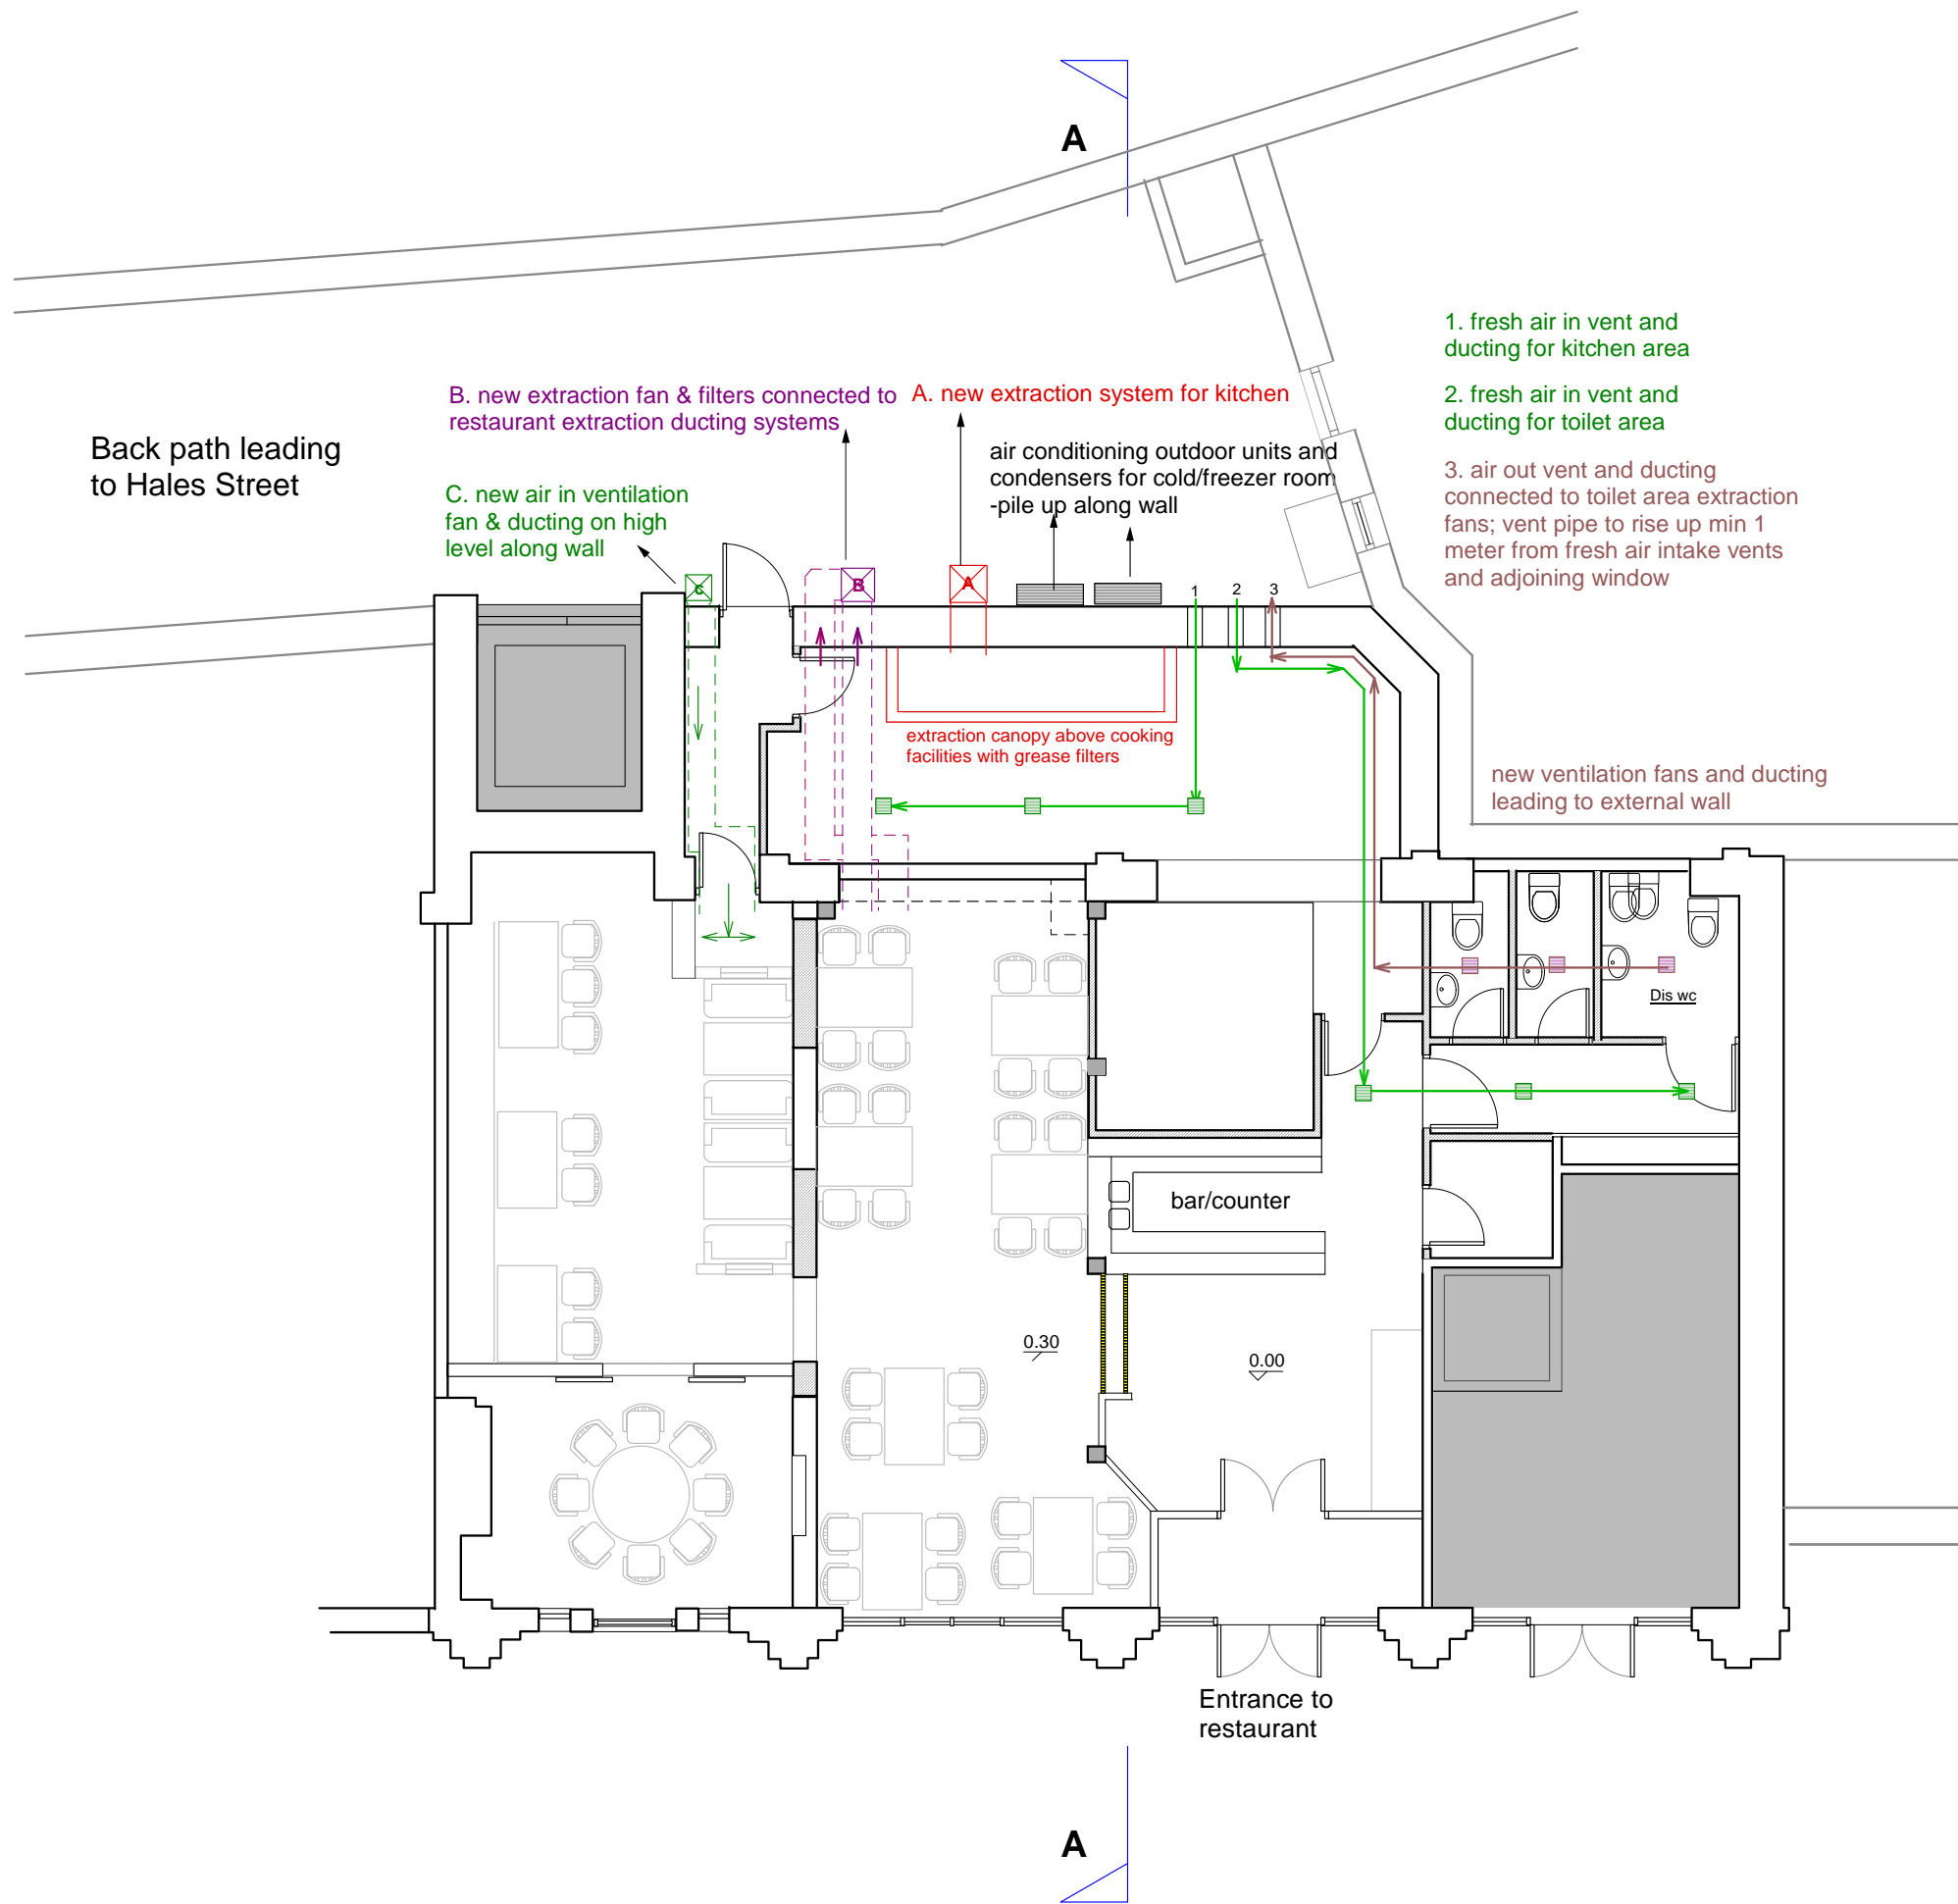

NEW IMAGE DESIGN
 2A Tiverton Road
 London N18 1DW
 Tel: 02083456883


Project Site: SHU XIANG GE
 The Old Fire Station
 Hale Street
 Coventry CV1 1JA



Client: [REDACTED]

Drawing Title:
Proposed Floor Plan

Drawing No.:
518/PL/04

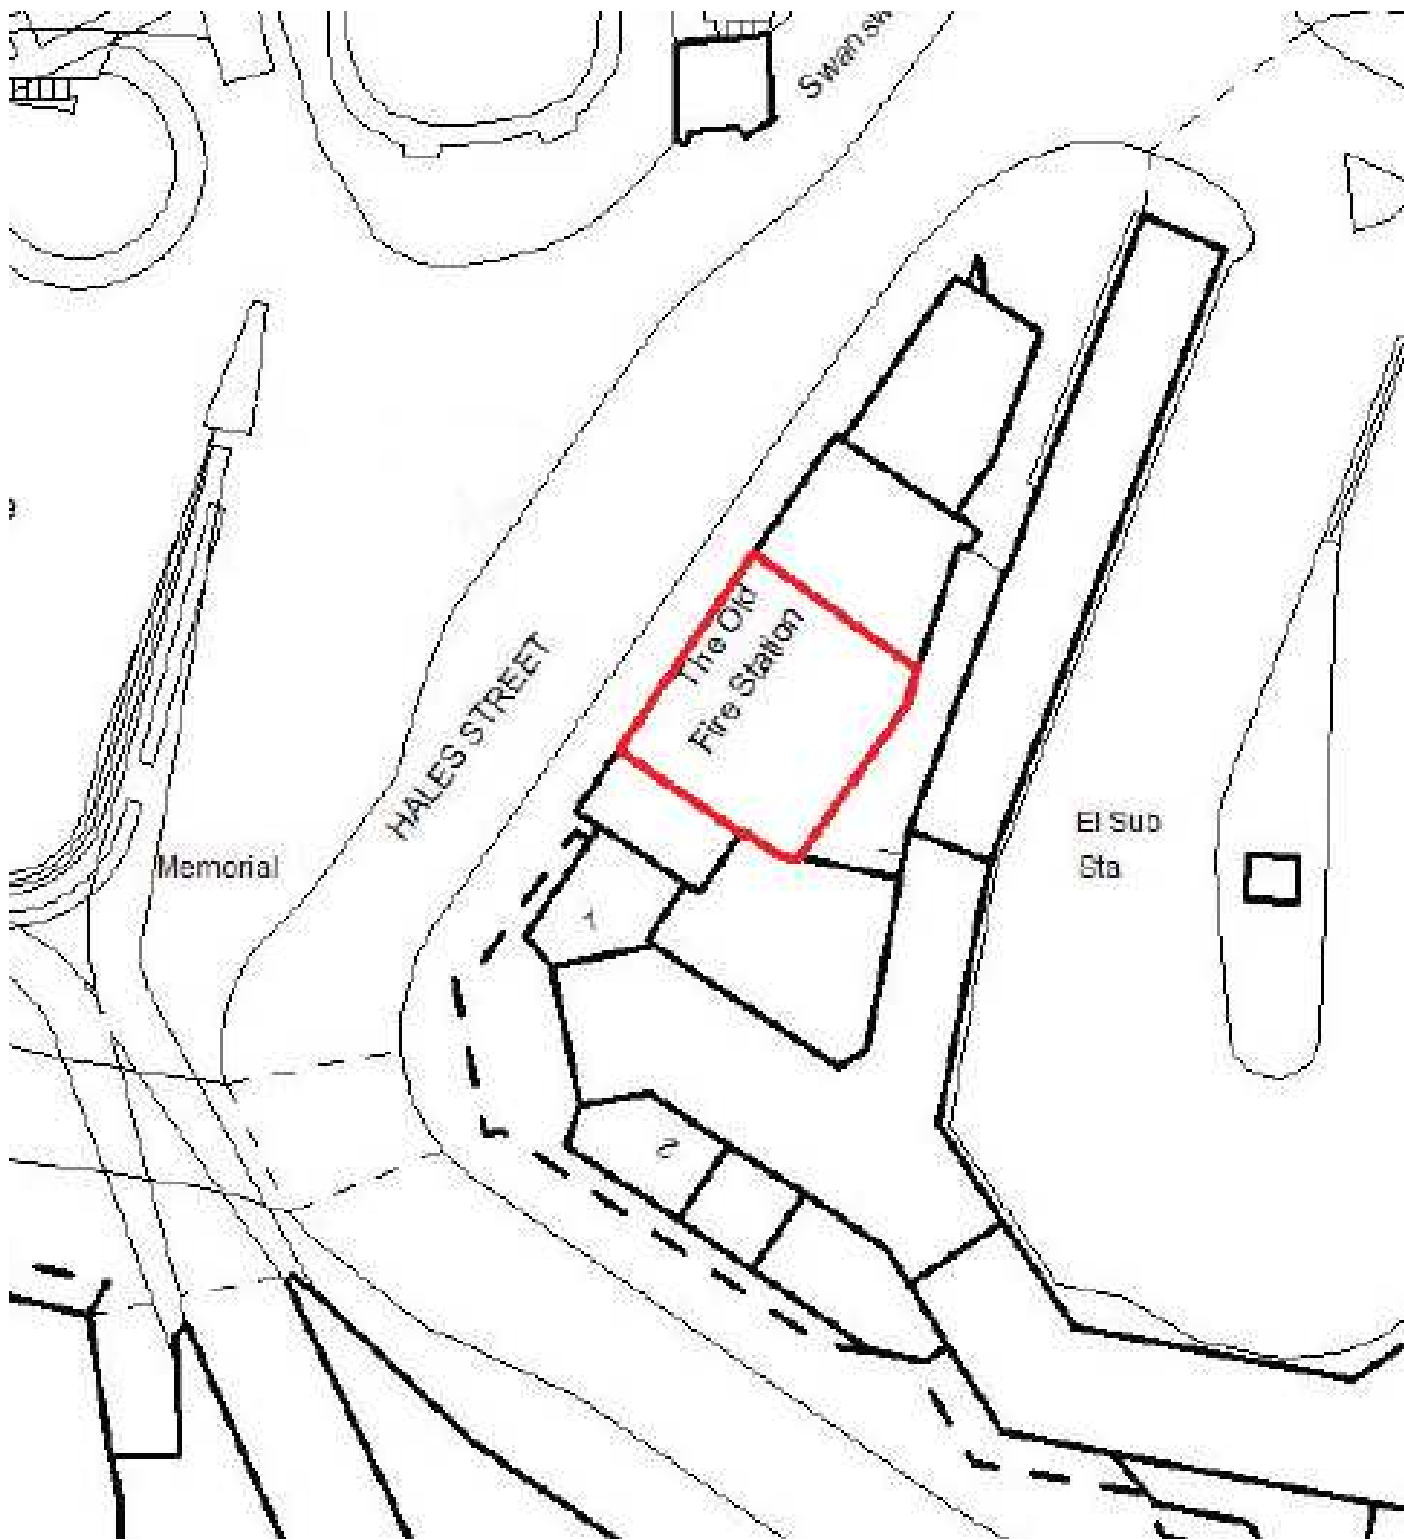Date: Dec/2019	Scale: 1:100 @ A3	Rev:
-------------------	----------------------	------



 NEW IMAGE DESIGN 2A Tiverton Road London N18 1DW Tel: 02083456883		
Project Site: SHU XIANG GE The Old Fire Station Hale Street Coventry CV1 1JA		
Client: 		
Drawing Title: Block Plan		
Drawing No.: 518/PL/02		
Date: Dec/2019	Scale: 1:500 @ A4	Rev: